


Proposed New Site No. 5
 HORST DÖRNER
 Site Plan

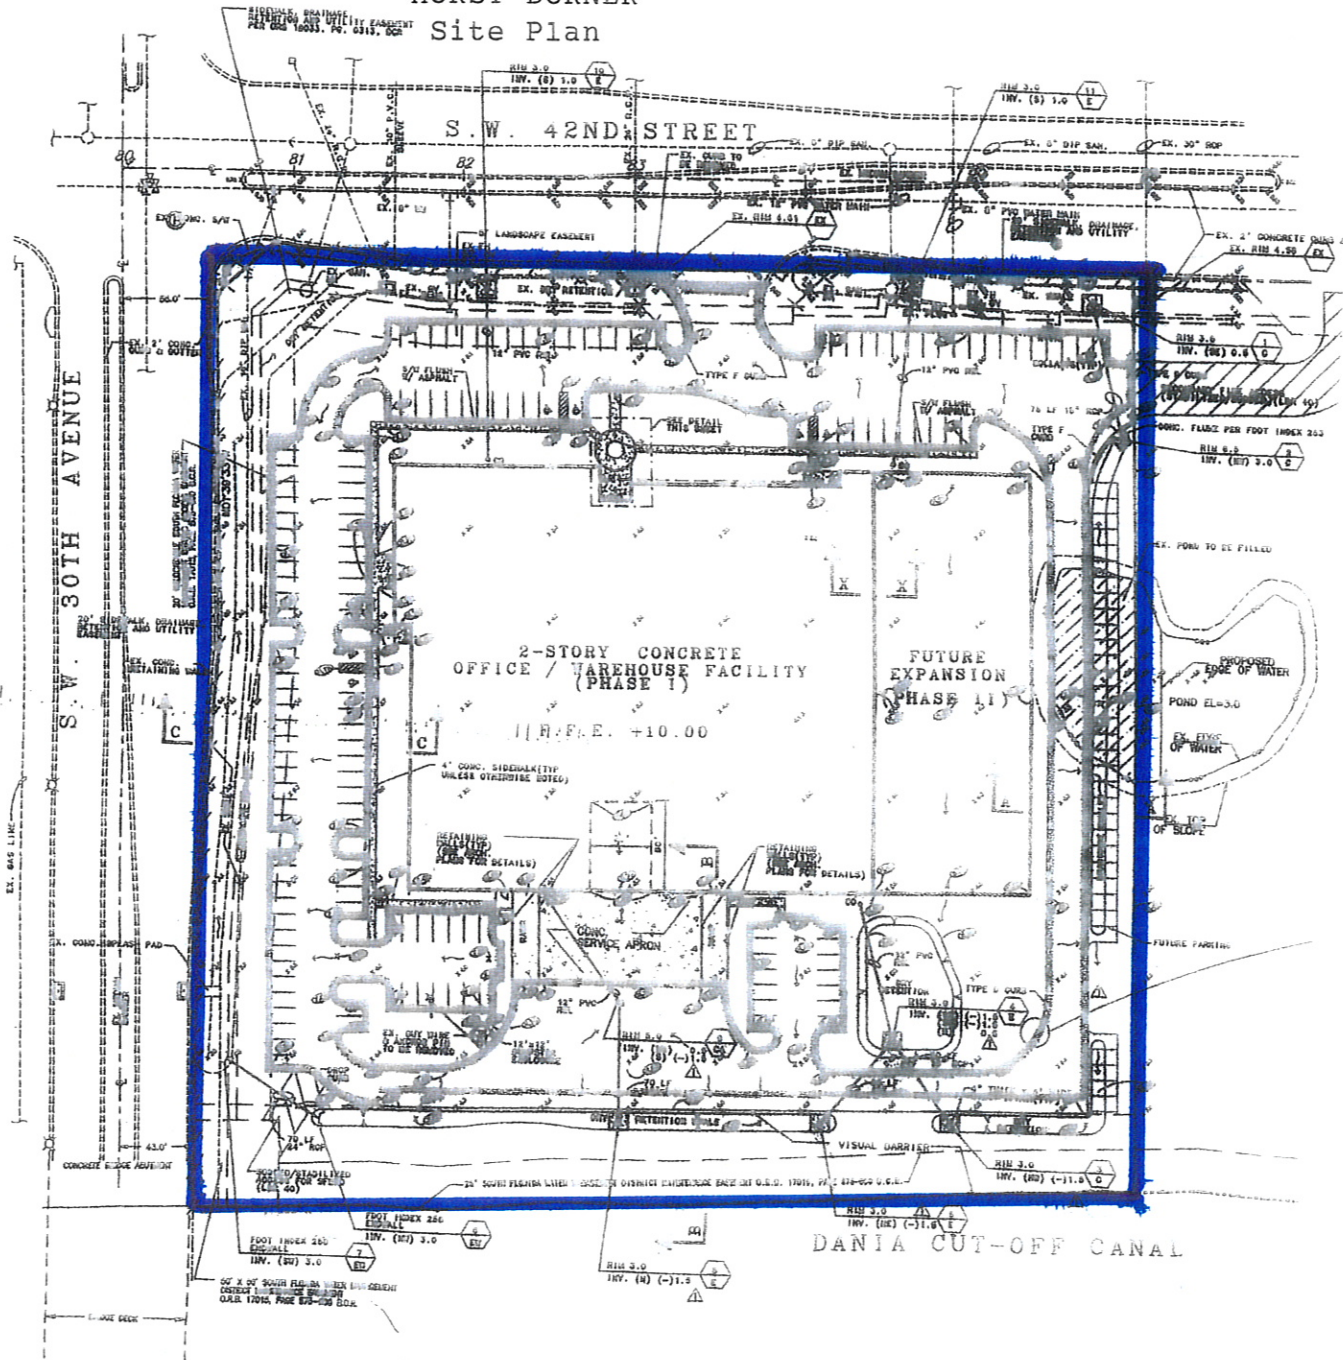

RHON ERNEST-JONES
 CONSULTING ENGINEERS, INC.
 2330 UNIVERSITY DRIVE
 CORAL SPRINGS, FLORIDA 33065
 (954) 344-0868

NO.	DESCRIPTION	BY	DATE	CHK'D

DATE: 0/07
 DESIGNED BY: RE-J
 DRAWN BY: KJK
 CHECKED BY: RE-J

WARTSILA NSD FACILITY
 PAVING, GRADING AND DRAINAGE PLAN
 CITY OF HOLLYWOOD BROWARD COUNTY FLORIDA
 SCALE: 1"=40' JOB No.: 98-1101-0700 SHEET: C-2 OF 6