


Building Plan & Electrical

700
Bartley Chester Road

**Givaudan Fragrances
Area to be Activated
40,000 SF**

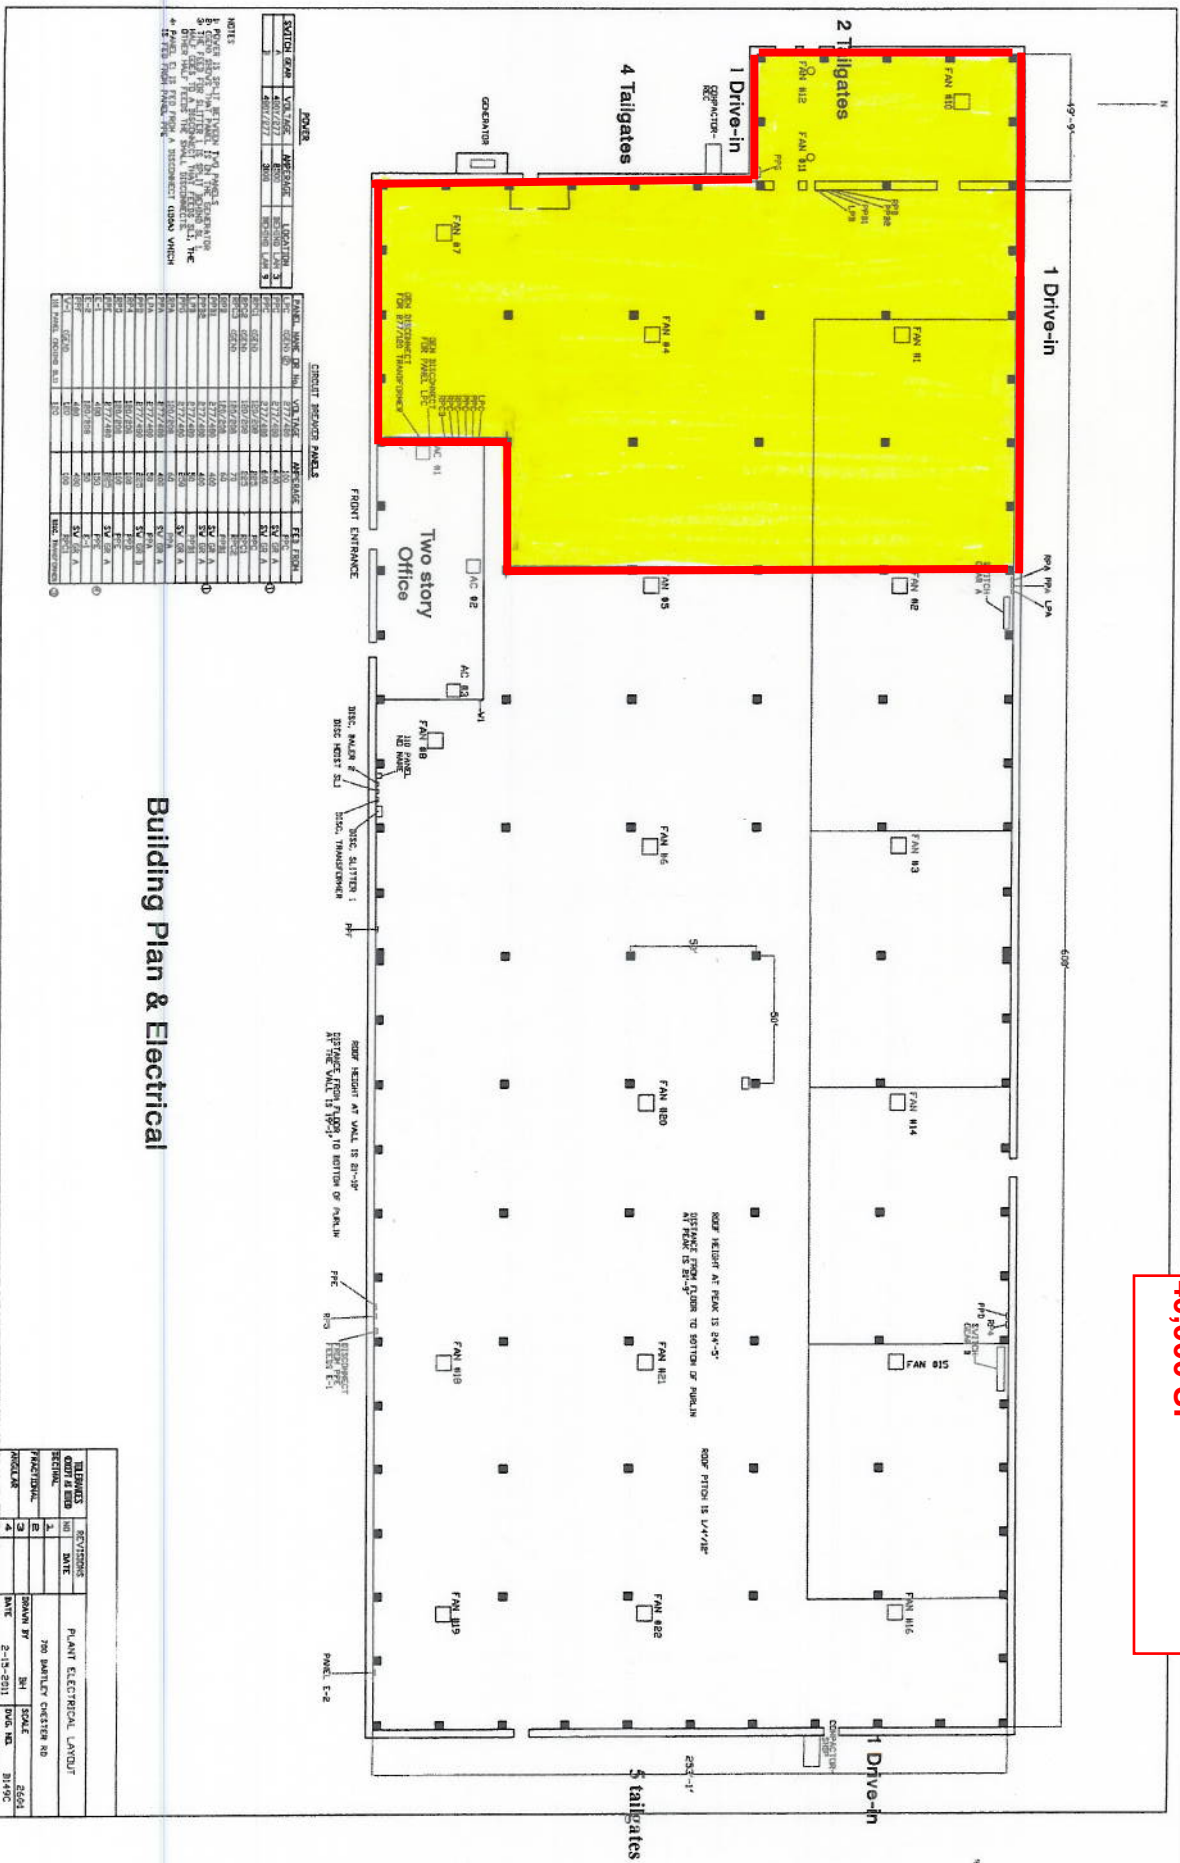

POWER

SCHEDULE	NO.	SYMBOL	DESCRIPTION	LOCATION
1	1	SW	SWITCH	ROOM 101
2	2	SW	SWITCH	ROOM 102
3	3	SW	SWITCH	ROOM 103

CONDUIT BETWEEN PANELS

PANEL	LINE	NO.	TYPE	SIZE	LENGTH	FEET	FROM	TO
1	1	1	1/2"	1/2"	100	100	101	102
1	2	2	1/2"	1/2"	100	100	102	103
1	3	3	1/2"	1/2"	100	100	103	104
1	4	4	1/2"	1/2"	100	100	104	105
1	5	5	1/2"	1/2"	100	100	105	106
1	6	6	1/2"	1/2"	100	100	106	107
1	7	7	1/2"	1/2"	100	100	107	108
1	8	8	1/2"	1/2"	100	100	108	109
1	9	9	1/2"	1/2"	100	100	109	110
1	10	10	1/2"	1/2"	100	100	110	111
1	11	11	1/2"	1/2"	100	100	111	112
1	12	12	1/2"	1/2"	100	100	112	113
1	13	13	1/2"	1/2"	100	100	113	114
1	14	14	1/2"	1/2"	100	100	114	115
1	15	15	1/2"	1/2"	100	100	115	116
1	16	16	1/2"	1/2"	100	100	116	117
1	17	17	1/2"	1/2"	100	100	117	118
1	18	18	1/2"	1/2"	100	100	118	119
1	19	19	1/2"	1/2"	100	100	119	120

NOTES

- POWER IS SUPPLIED BY THE CITY OF BARTLEY CHESTER ROAD.
- ALL ELECTRICAL WORK SHALL BE IN ACCORDANCE WITH THE NATIONAL ELECTRICAL CODE (NEC) AND ALL LOCAL ORDINANCES.
- ALL ELECTRICAL WORK SHALL BE PERFORMED BY A LICENSED ELECTRICIAN.
- ALL ELECTRICAL WORK SHALL BE SUBJECT TO INSPECTION BY THE CITY OF BARTLEY CHESTER ROAD.
- IF THE PANEL PANEL NO. IS NOT SHOWN, IT IS ASSUMED TO BE THE SAME AS THE PREVIOUS PANEL.

Building Plan & Electrical

REVISIONS	DATE	BY	DESCRIPTION
1	2-15-2011	SH	PLANT ELECTRICAL LAYOUT
2			
3			
4			

PROJECT: 700 BARTLEY CHESTER RD
SCALE: AS SHOWN
DATE: 2-15-2011
DRAWN BY: SH
CHECKED BY: SH
DATE: 2-15-2011