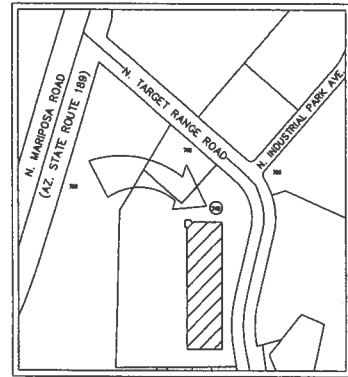
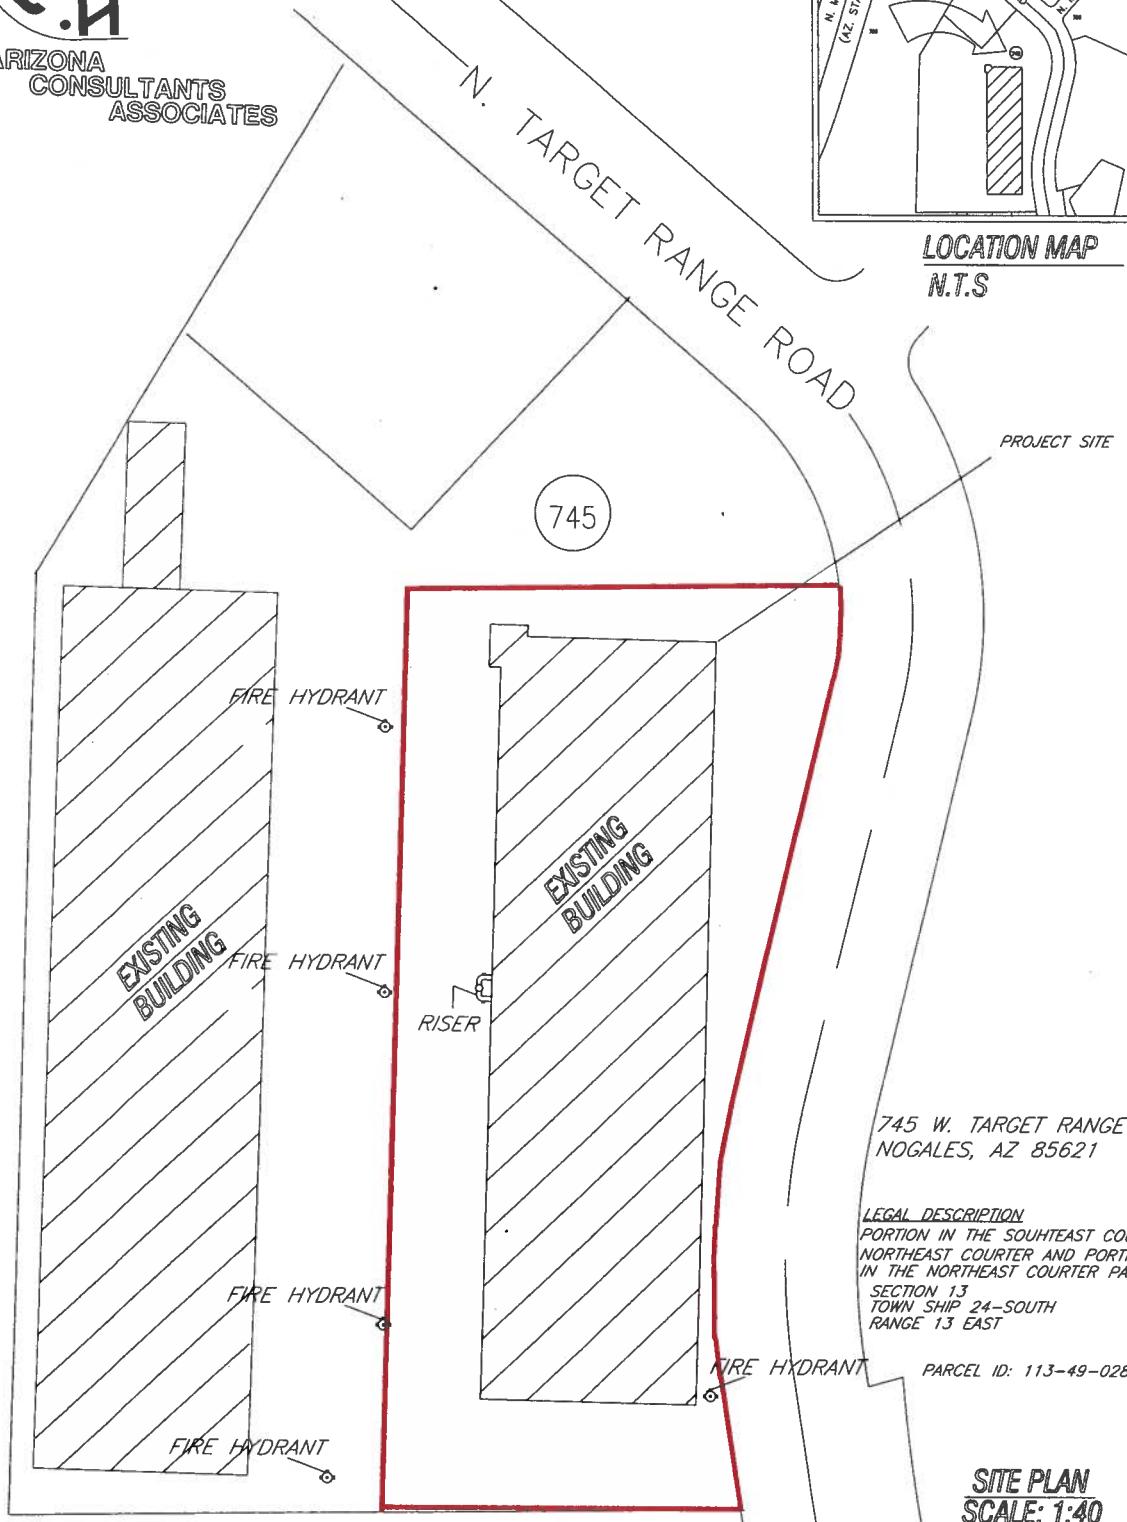

 ARIZONA
 CONSULTANTS
 ASSOCIATES



LOCATION MAP
N.T.S.



745 W. TARGET RANGE RD
NOGALES, AZ 85621

LEGAL DESCRIPTION
 PORTION IN THE SOUTHEAST COURTER
 NORTHEAST COURTER AND PORTION
 IN THE NORTHEAST COURTER PAD.
 SECTION 13
 TOWNSHIP 24-SOUTH
 RANGE 13 EAST

PARCEL ID: 113-49-028 B

SITE PLAN
SCALE: 1:40

MODIFIED FIRE DEPARTMENT
 APPROVED BY: [Signature]
 DATE: 12/11/10

DRAWN: RB
 CHECKED: A.C.A.
 DATE: 12/08/10
 SCALE:
 JOB NO.:
 SHEET: 7
 OF 3 SHEETS

A.C.A. ARIZONA
 CONSULTANTS
 ASSOCIATES
 934 BELMONT STREET, SUITE 2
 NOGALES, AZ, P.O. BOX 7373
 (520) 287-7910
 85621

PROPOSED STOCK PILES FOR:
BECTON DICKINSON MEDICAL SYSTEMS

REVISION	BY